 

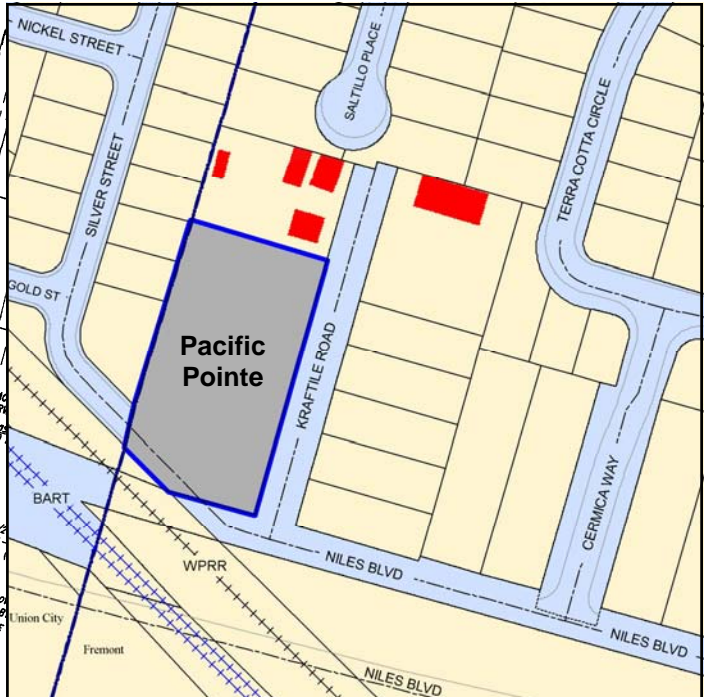


FOR ADDRESSING PURPOSES ONLY

SP60-0111 9/11/07 RC

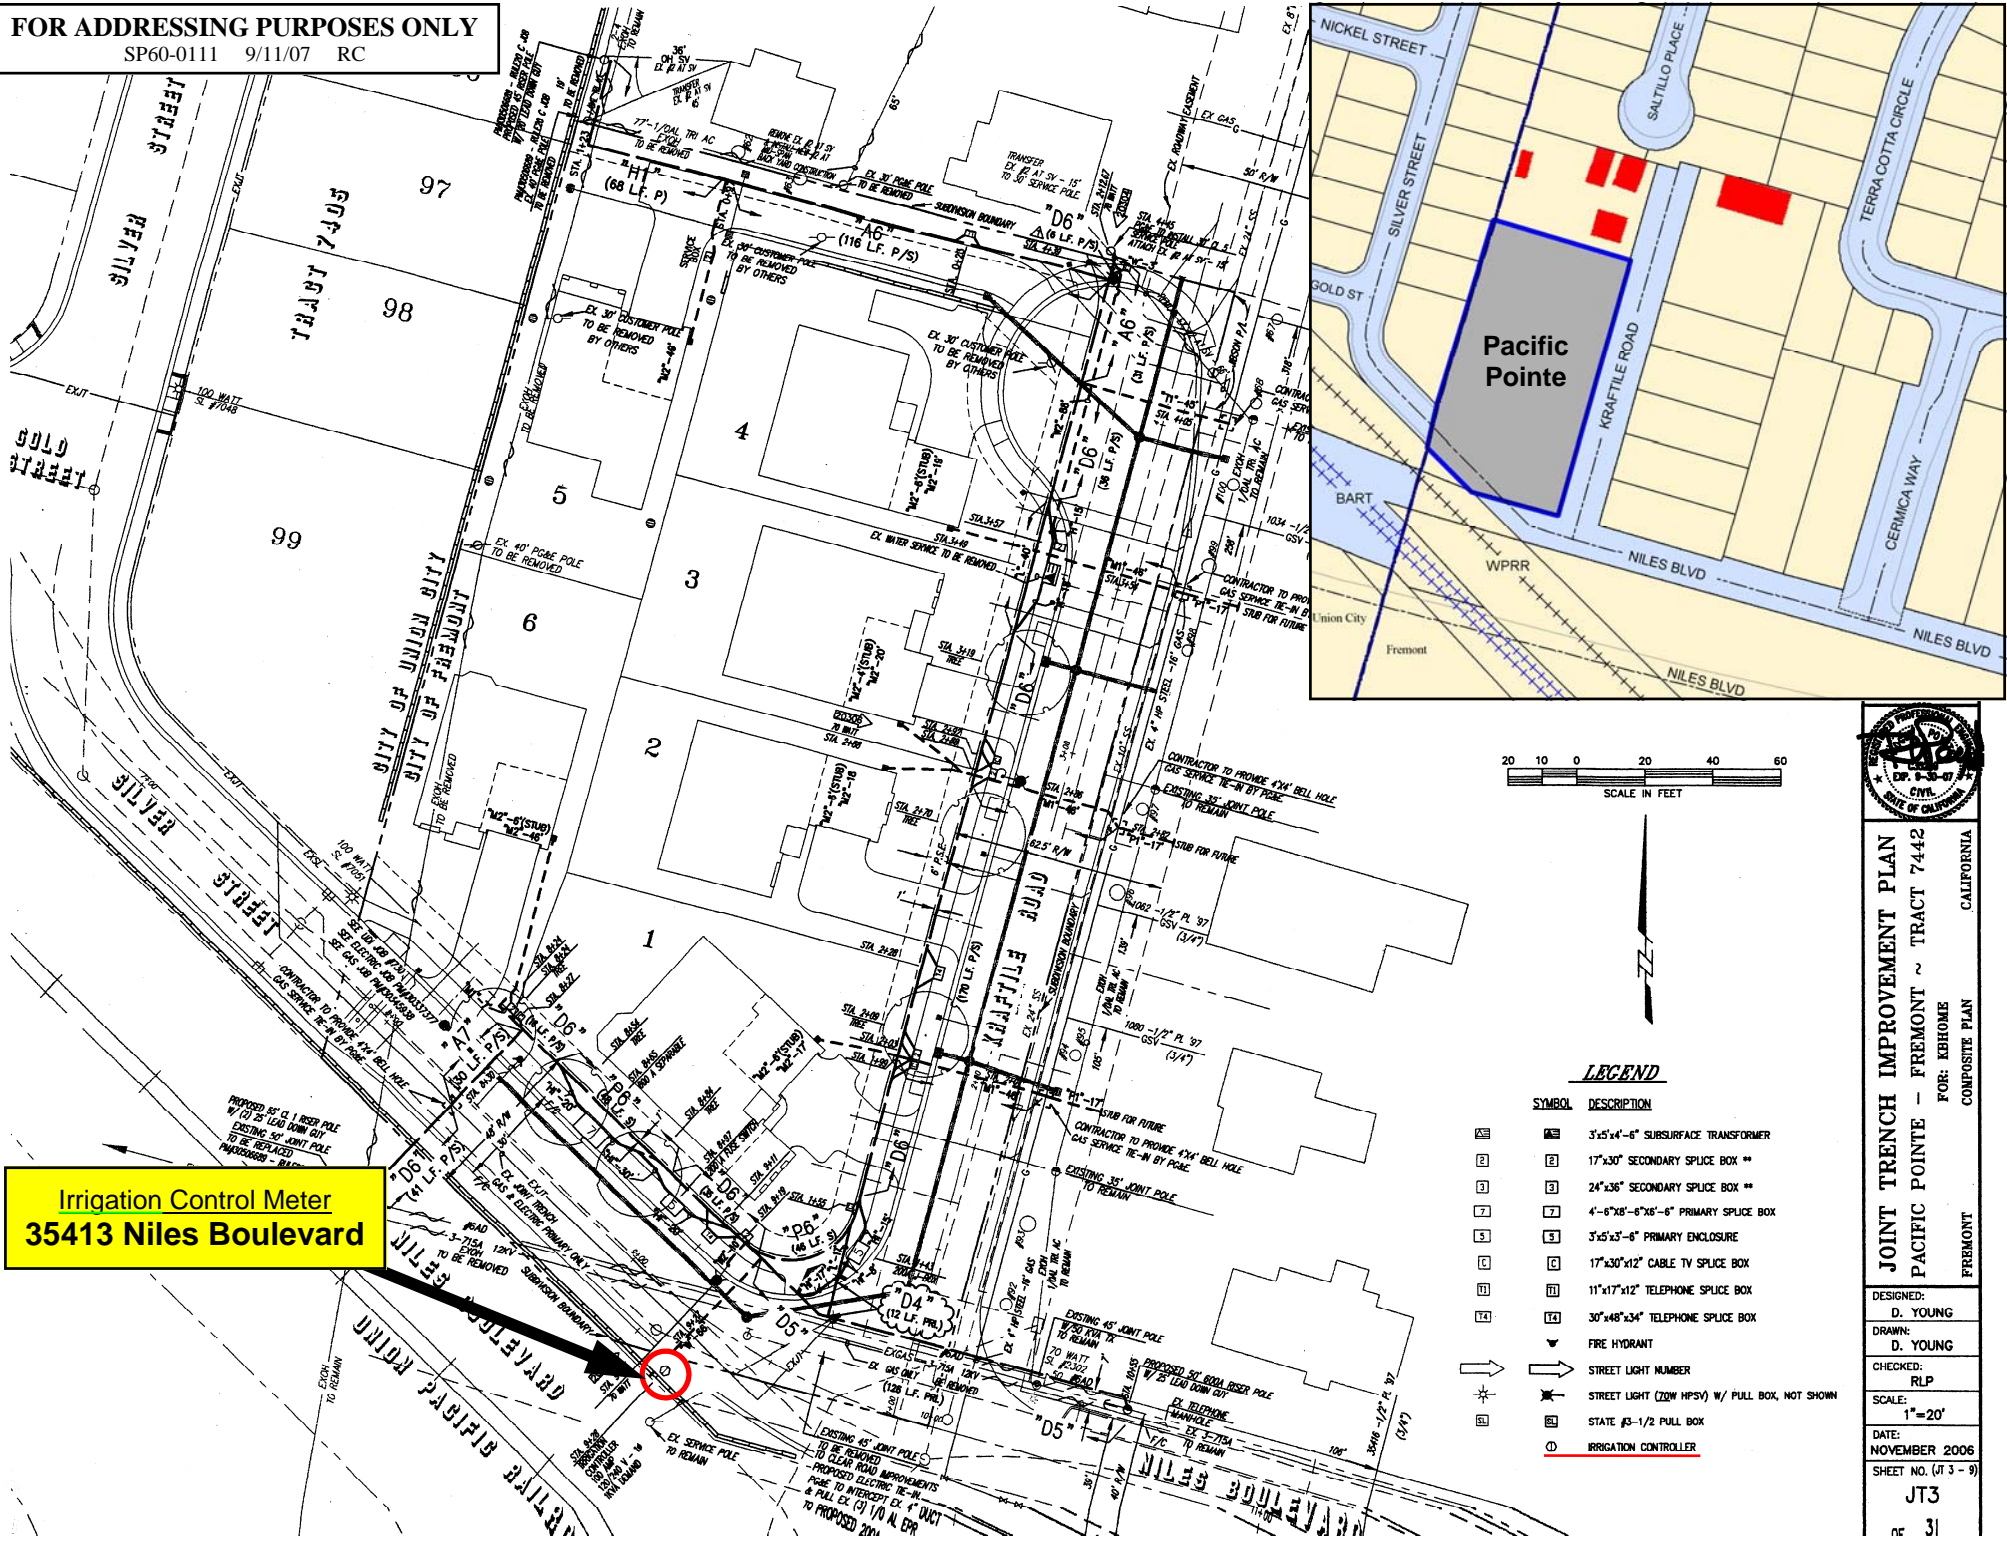

LEGEND

SYMBOL	DESCRIPTION
[Symbol]	3'x5'x4'-6" SUBSURFACE TRANSFORMER
[Symbol]	17"x30" SECONDARY SPLICE BOX **
[Symbol]	24"x36" SECONDARY SPLICE BOX **
[Symbol]	4'-6"x6"-6"x6"-6" PRIMARY SPLICE BOX
[Symbol]	3'x5'x5'-6" PRIMARY ENCLOSURE
[Symbol]	17"x30"x12" CABLE TV SPLICE BOX
[Symbol]	11"x17"x12" TELEPHONE SPLICE BOX
[Symbol]	30"x48"x34" TELEPHONE SPLICE BOX
[Symbol]	FIRE HYDRANT
[Symbol]	STREET LIGHT NUMBER
[Symbol]	STREET LIGHT (200W HPSV) W/ FULL BOX, NOT SHOWN
[Symbol]	STATE #3-1/2 PULL BOX
[Symbol]	<u>IRRIGATION CONTROLLER</u>



JOINT TRENCH IMPROVEMENT PLAN
PACIFIC POINT - FREMONT ~ TRACT 7442
 FOR: K&HOMES
 COMPOSITE PLAN
 FREMONT CALIFORNIA

DESIGNED: D. YOUNG
 DRAWN: D. YOUNG
 CHECKED: RLP
 SCALE: 1"=20'
 DATE: NOVEMBER 2006
 SHEET NO. (13 - 9)
JT3
 OF 31

Irrigation Control Meter
35413 Niles Boulevard