



KATO ROAD

KATO ROAD



FUTURE DEVELOPMENT BY KB HOME

FUTURE DEVELOPMENT BY KB HOME

FOR ADDRESSING PURPOSES ONLY

9/28/2006
 CLK
 SP# 34-244

• NOTE
 ALL DECORATIVE POST TOP LIGHTS AND
 BOLLARDS TO BE CIRCUITED TO METERS
 (NEXT SUBMITTAL WILL REFLECT THIS)

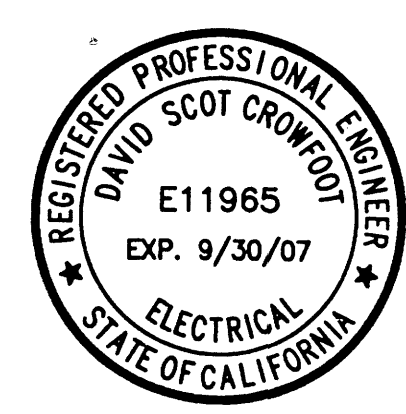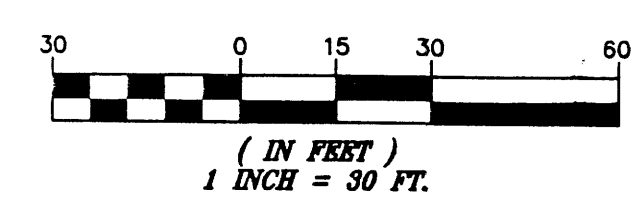

NO.	DATE	BY	CHK	APP	REV.	DESCRIPTION

Siemone
 DESIGN SERVICES, INC.
 JOINT TRENCH UTILITY DESIGN • STREET LIGHTING • UTILITY CONSULTING
 2825 CROW COURT, ANTIPOCH, CA 94509
 PHONE (925) 756-0800 • FAX (925) 756-0806

PREPARED FOR:

STREET LIGHTING PLAN
 CASTILLEJA
 SANTA CLARA DEVELOPMENT
 CALIFORNIA
 FREMONT

DATE: JUNE 15, 06
 SCALE: 1" = 30'
 DESIGNED: C.PENN
 DRAWN: CP
 JOB NO. 04-164

SHEET
SL-2
 OF SHEETS